

# A D D E N D U M N O . 7

---

**ROOF REPLACEMENT AND RELATED WORK  
WESTERN ELEMENTARY SCHOOL  
NAUGATUCK, CT  
KBA #15037.00**

Date: February 17, 2016  
Page: 1 of 1

---

The following changes to the Project Manual shall become a part of the Drawings, Specifications, Bidding Requirements and Contract Documents; superseding previously issued Drawings, Specifications, Bidding Requirements, Contract Documents and Addenda, to the extent modified by this Addendum.

---

## **CHANGES TO SPECIFICATIONS**

### **DIVISION 07 – THERMAL AND MOISTURE PROTECTION**

Section 07 53 12 “Ethylene-Propylene-Diene-Monomer EPDM Roofing”

Paragraph 2.3E

**Change to read:**

- E. Seaming Material: Manufacturer's standard, synthetic-rubber polymer primer and **6”**-wide minimum, butyl splice tape with release film.


## **CHANGES TO DRAWINGS**

### **MEP-01 MEP ROOF PLAN**

The existing make-up air unit on kitchen roof is not scheduled to be removed. See sketch SKA7.01.

## **ATTACHMENTS**

SKA-7.01

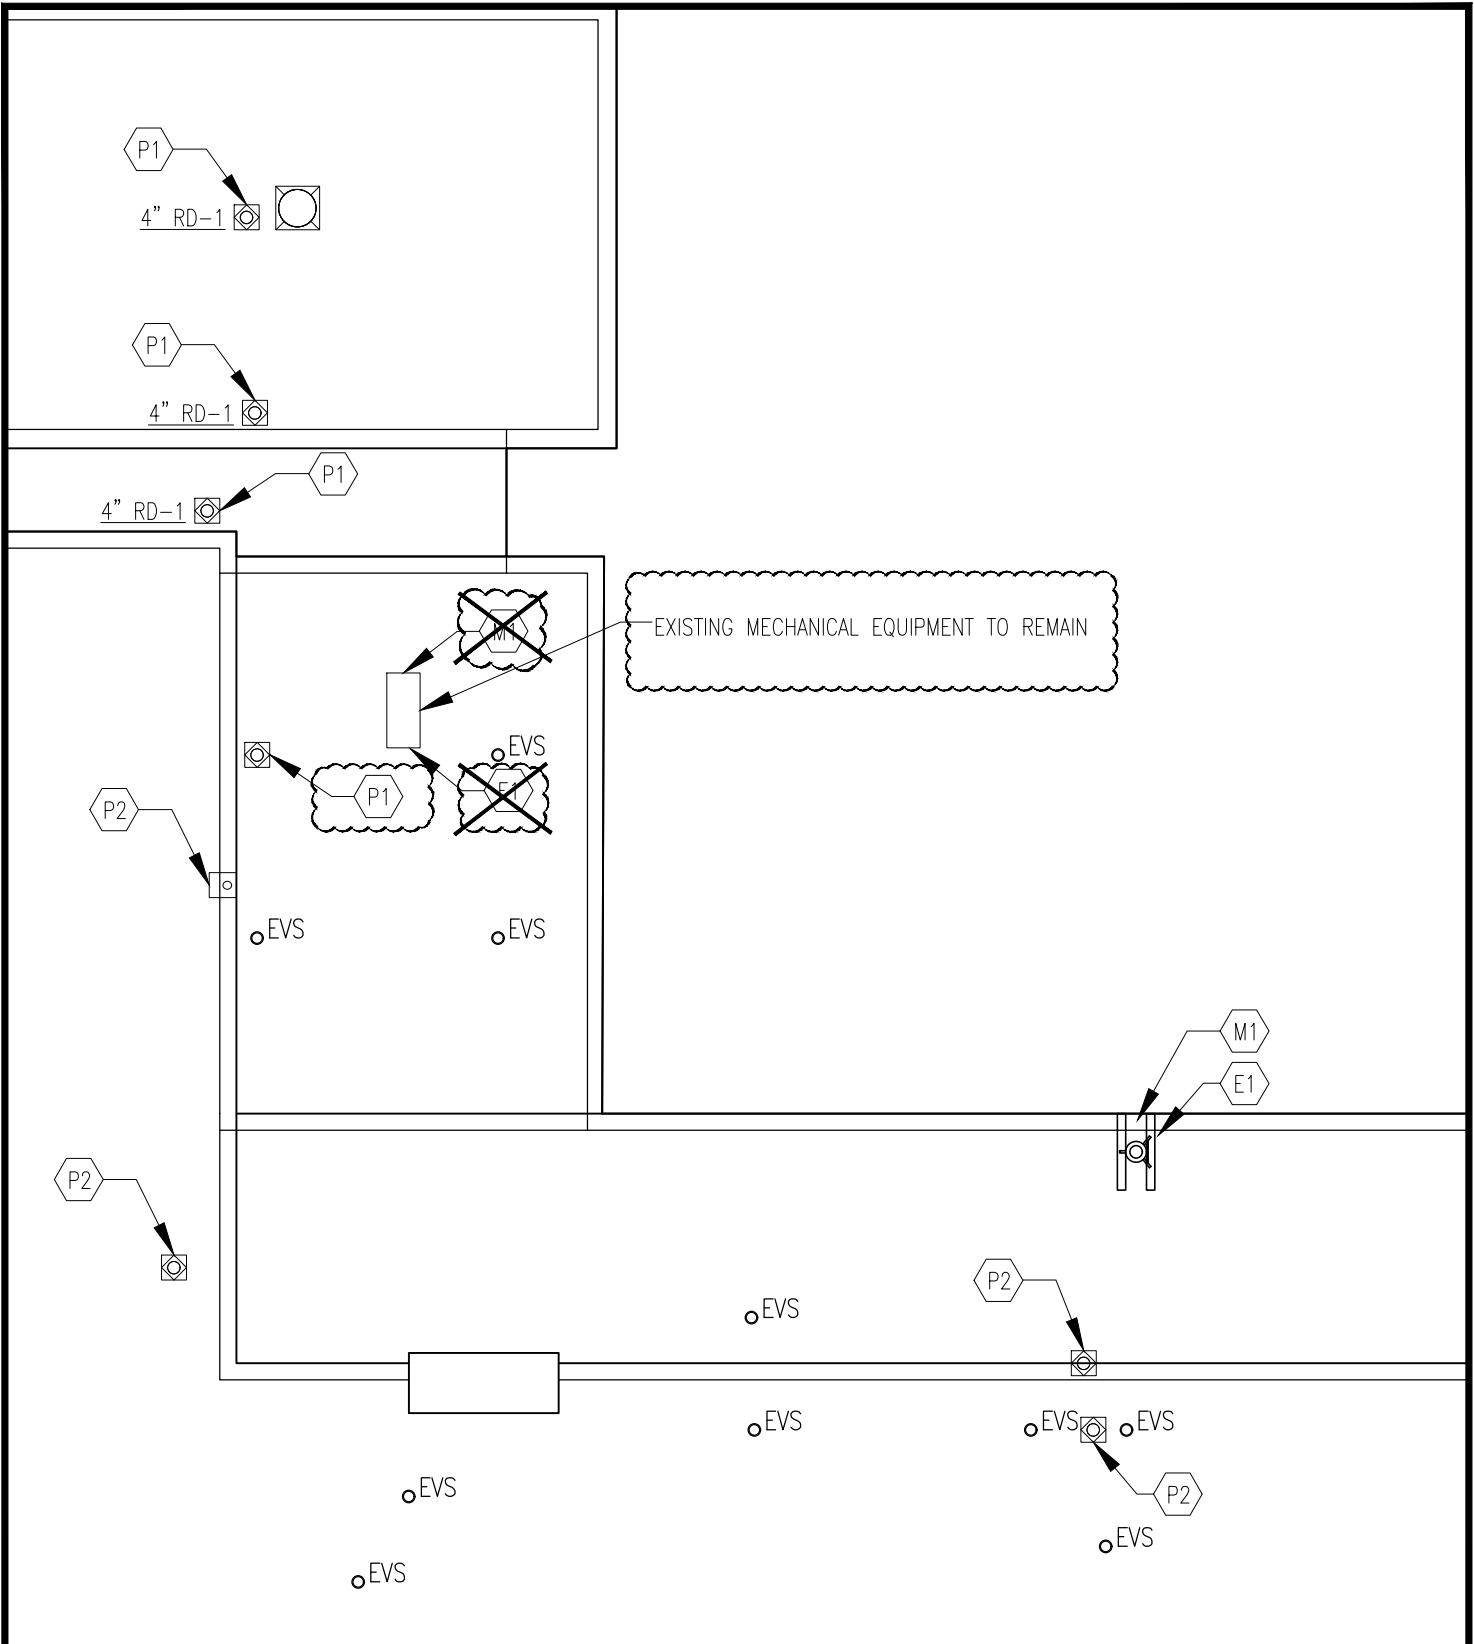

EXISTING MECHANICAL EQUIPMENT TO REMAIN



**KAESTLE BOOS**  
associates, inc

416 Slater Road, P.O. Box 2590  
New Britain, CT 06050-2590  
Ph: 860-229-0361 ▲ F: 860-229-5303

325 Foxborough Boulevard, Suite 100  
Foxborough, MA 02035  
Ph: 508-549-9906 ▲ F: 508-549-9907

Email: kba@kba-architects.com  
Web: www.kba-architects.com

CONSULTANT:

PROJECT:  
**ROOF  
REPLACEMENT  
AT WESTERN  
ELEMENTARY  
SCHOOL**

THIS SKETCH TO  
BE READ IN  
CONJUNCTION  
WITH THE  
CONTRACT  
DOCUMENTS

SKETCH GENERATED FOR:				
ADDENDUM	R.R.F.I.	A.S.I.	P.R.	C.C.D.
7	-	-	-	-

REFERENCE DETAIL/SHEET: MEP-01

TITLE: **(REVISED) PARTIAL DEMOLITON  
MECHANICAL PLAN**

DATE: 2/17/16	DRAWN: CC	DRAWING NO.:
SCALE: N.T.S.	PROJECT NO.: 15037.00	<b>SKA7.01</b>